




5/28/2014 11:48 AM
 -:\Projects\2014\214-019 canmore community housing corporation\3.0 drawings\3.2 contract documents\3.2.1 drawings\canmore community housing corporation\sheet\A5.01 unit plans.dwg

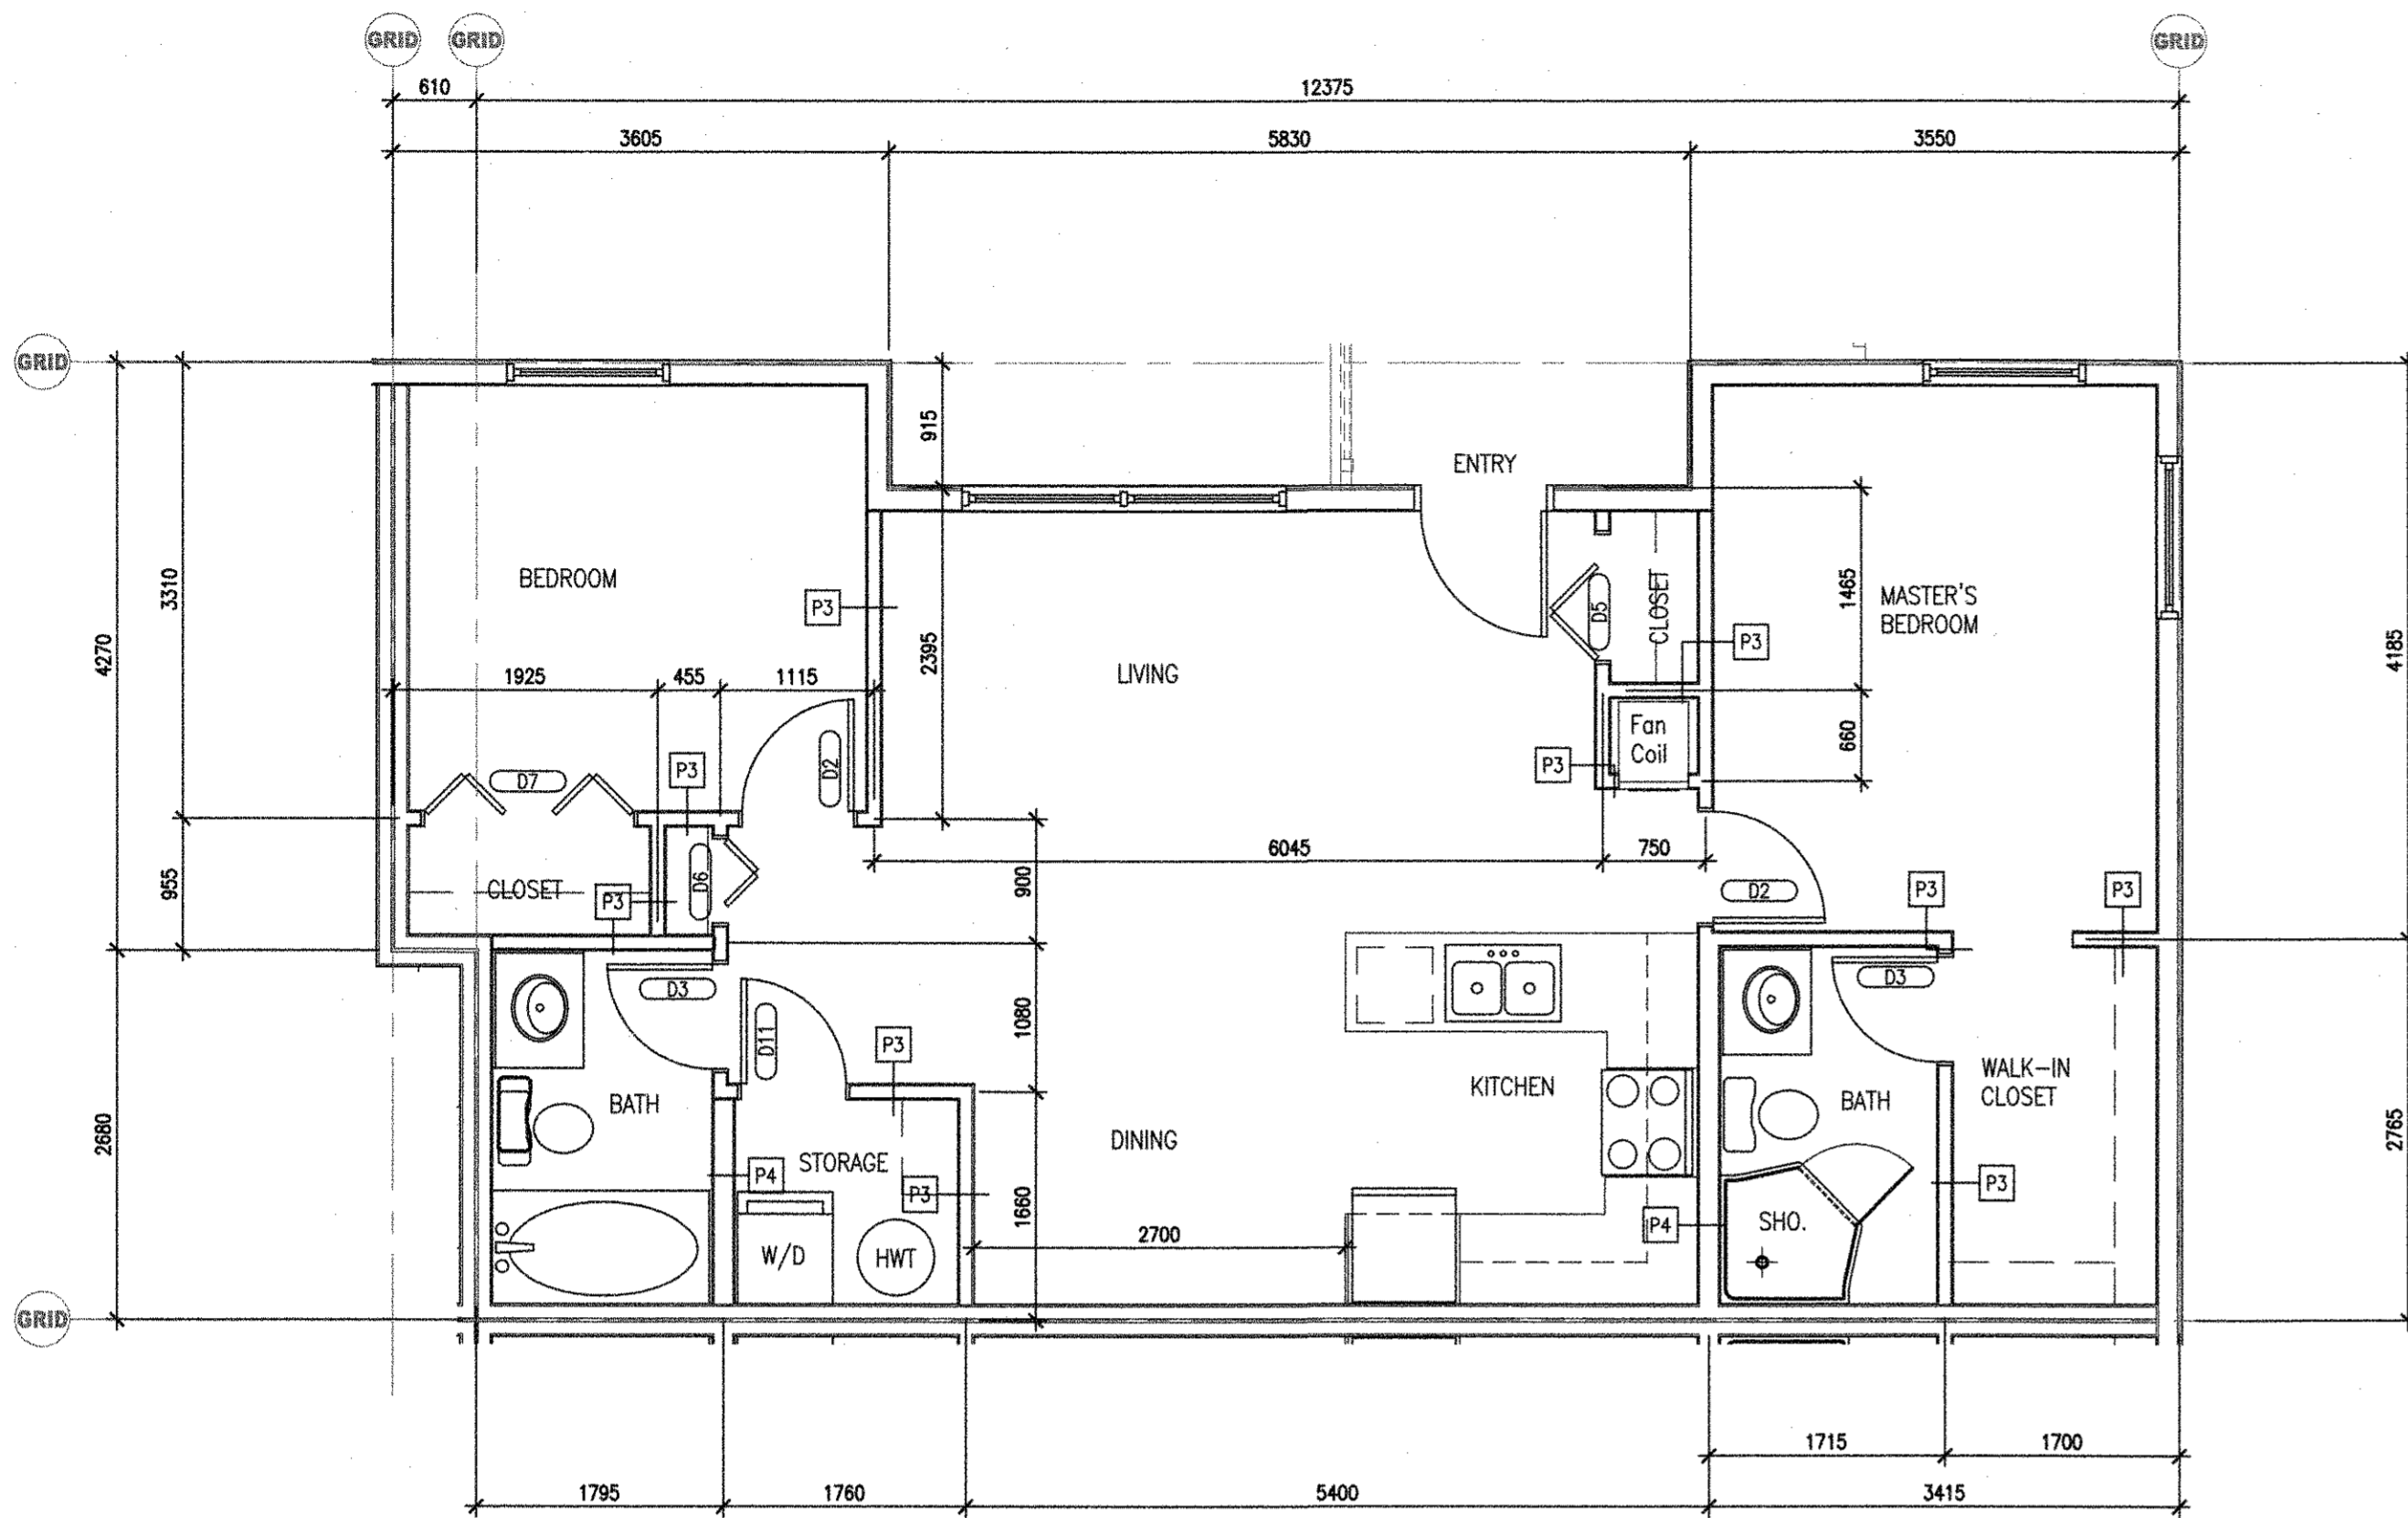

1 UNIT A TWO BEDROOM (AREA: 83.20 S.M.)
 A5.01 1:50

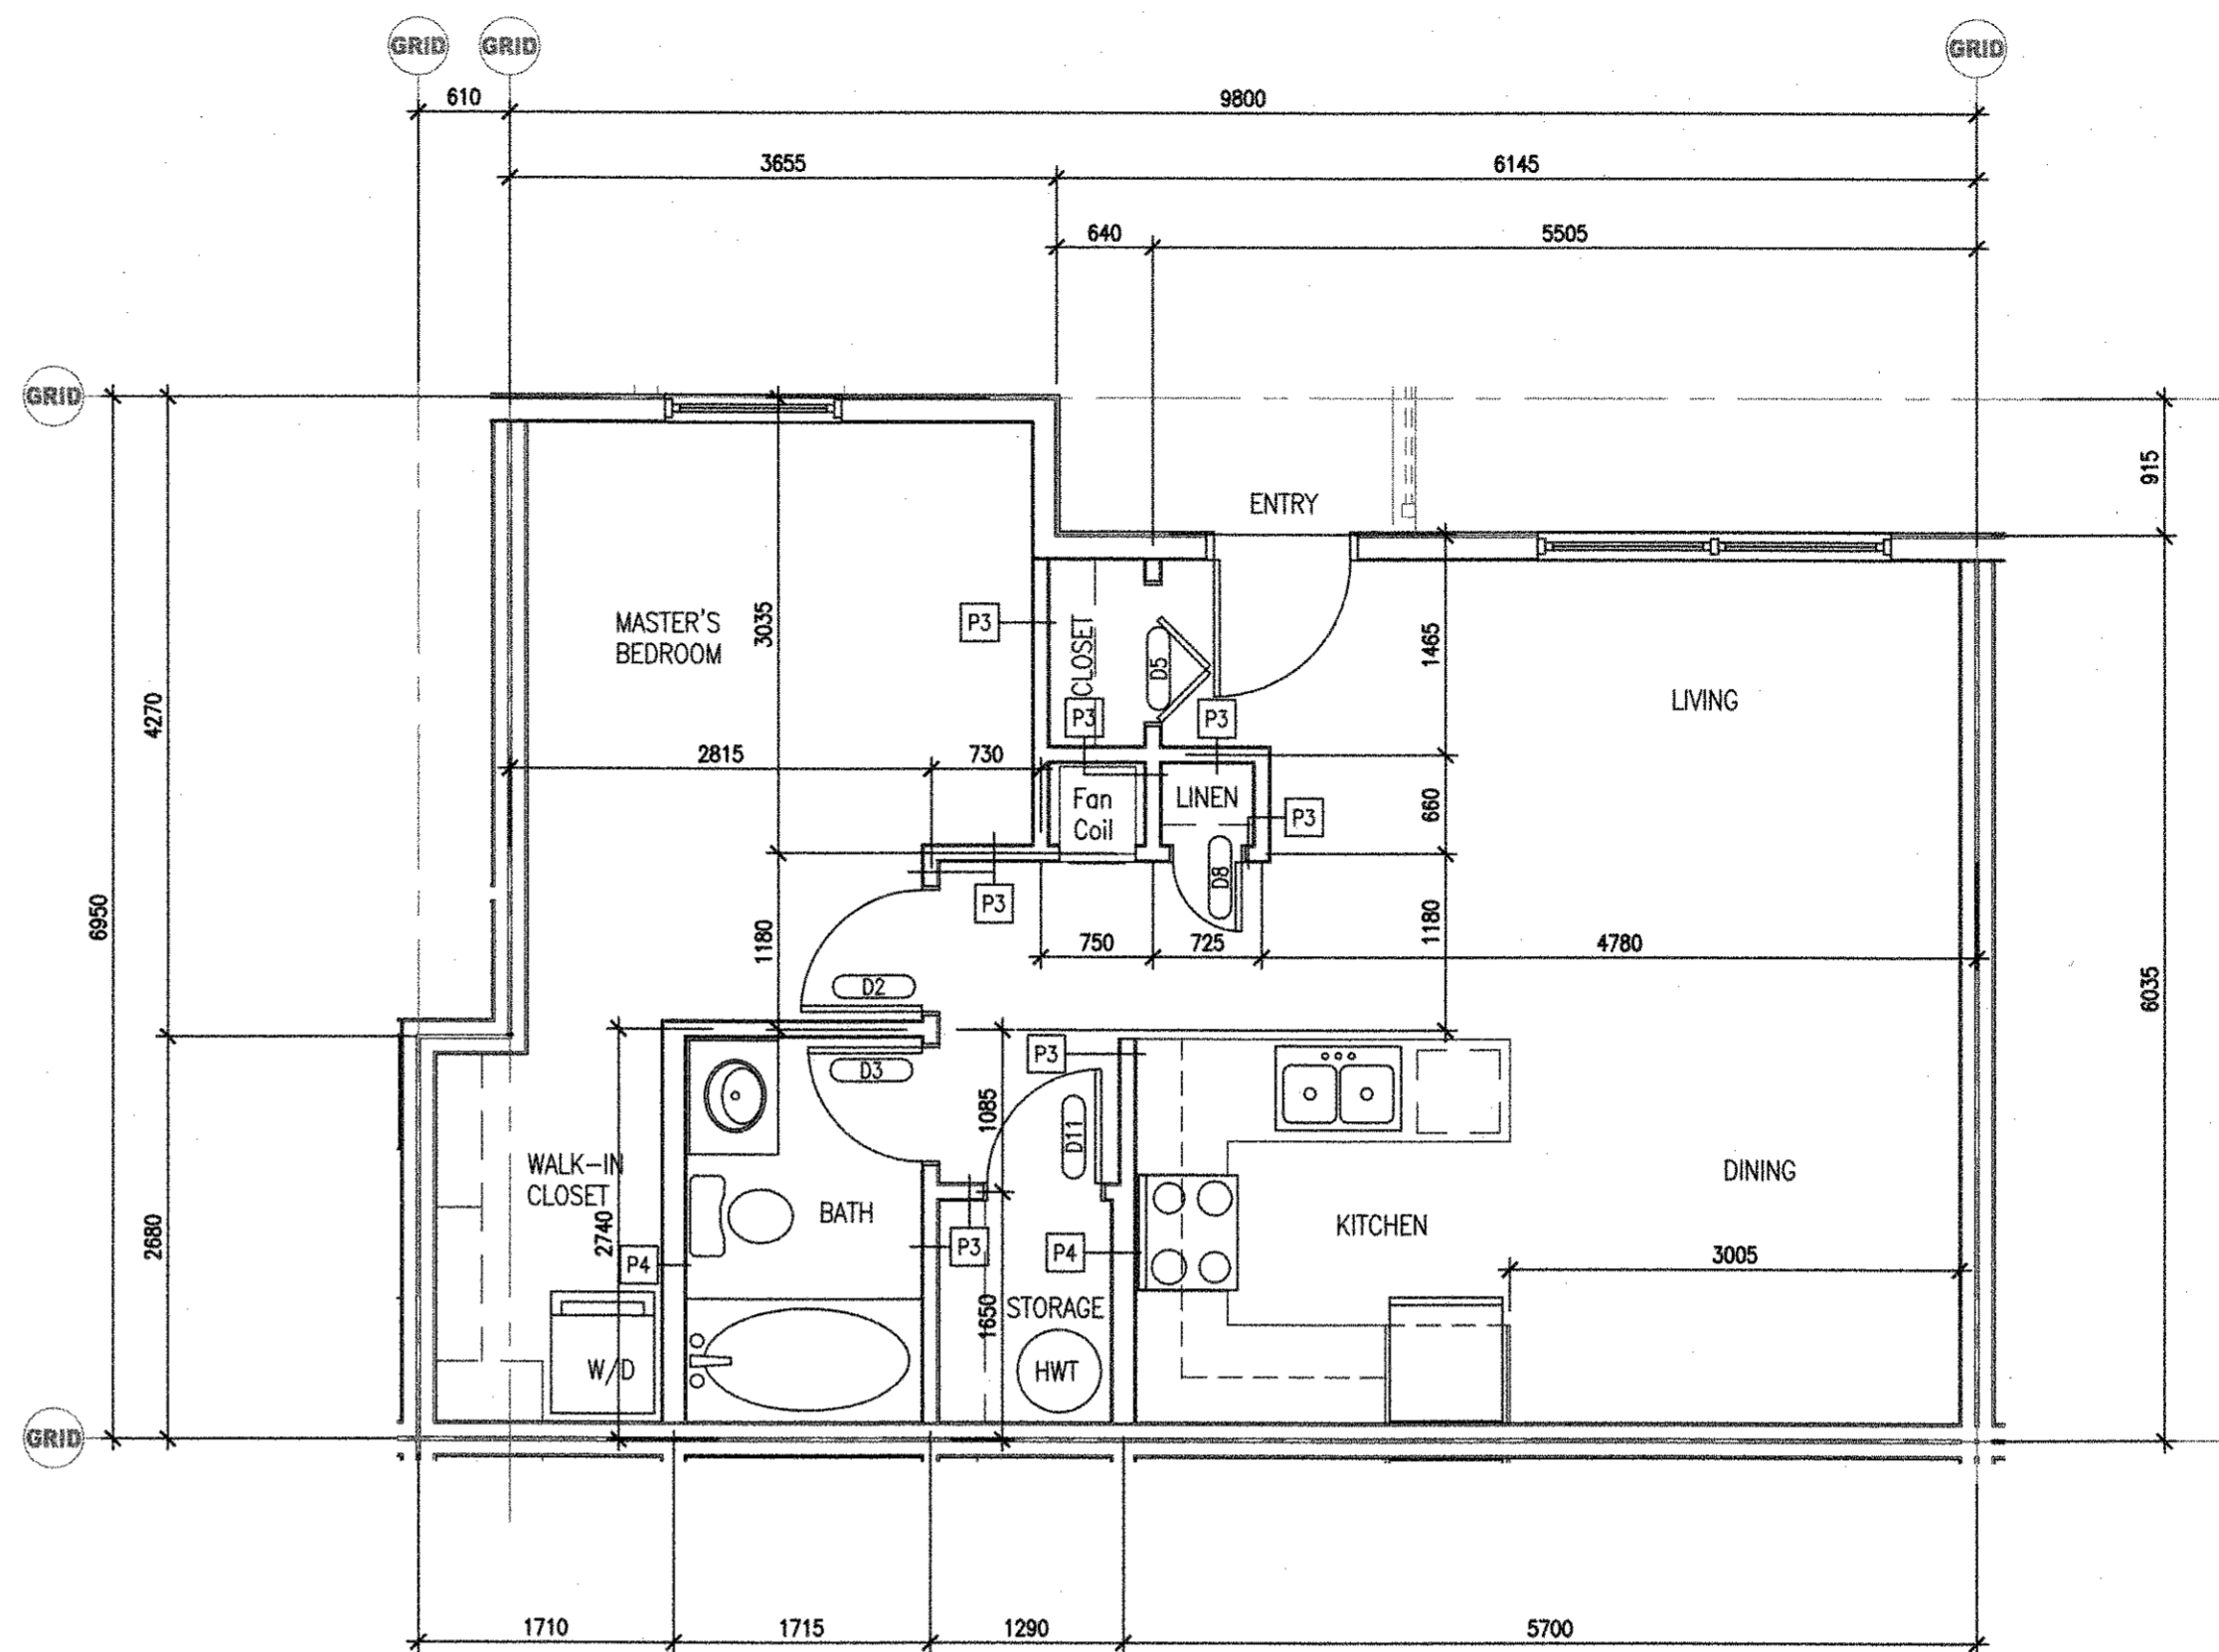

3 UNIT C ONE BEDROOM (AREA: 64.10 S.M.)
 A5.01 1:50

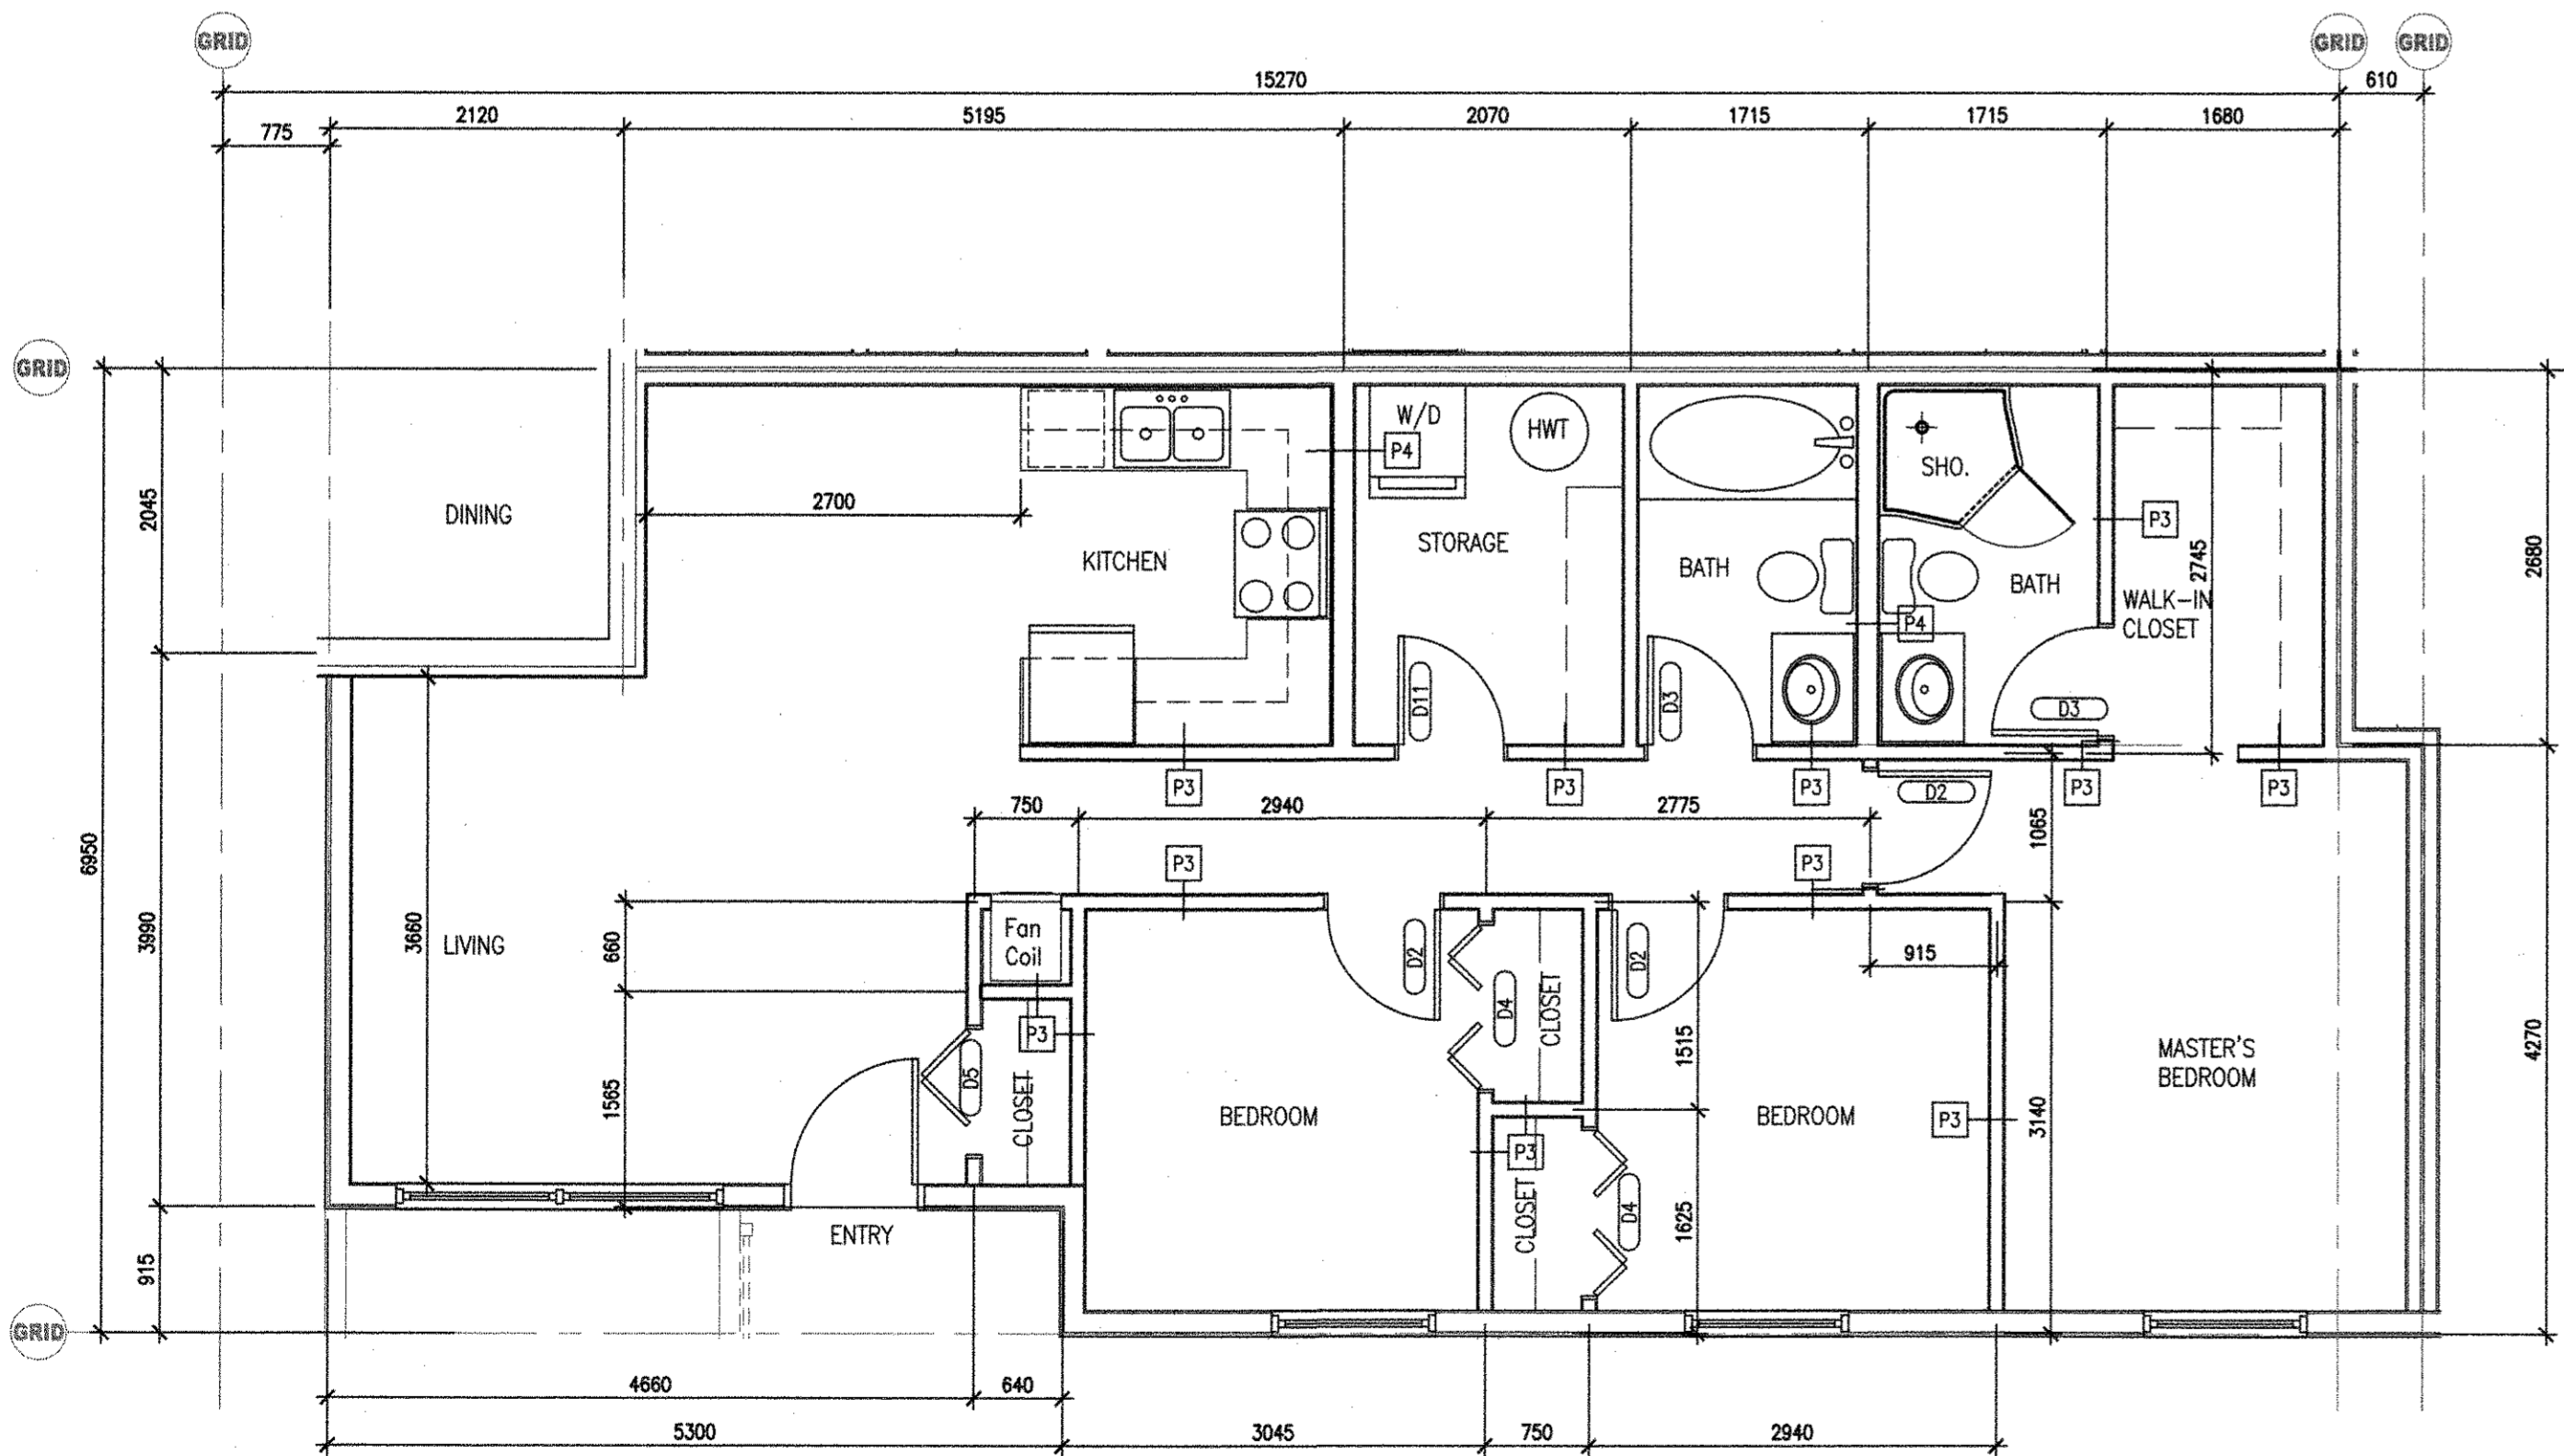

2 UNIT B THREE BEDROOM (AREA: 94.00 S.M.)
 A5.01 1:50

UNIT NOTES:

1. REFER TO DWGS. A2.01 AND 2.02 FOR OVERALL PLANS, EXTERIOR WALL, DOOR, WINDOW TAGS AND CONSTRUCTION ASSEMBLIES FOR UNIT DEMISING PARTITION WALL.
2. VERIFY ACTUAL ROUGH OPENINGS/CLEARANCES REQUIRED FOR ALL PLUMBING FIXTURES & APPLIANCES PRIOR TO LAYING OUT PARTITIONS.
3. ALL DIMENSIONS ARE TO CENTER OF STUD UNLESS NOTED OTHERWISE.
4. REFER TO A9.01 FOR FINISHES.

CONSTRUCTION NOTES

1. ONLY PARTIAL OF TOTAL WALL CONSTRUCTION BETWEEN UNITS HAS BEEN INDICATED FOR CLARITY, REFER TO DWG. A2.01 AND A2.02 FOR TYPICAL UNIT DEMISING WALL (P-1)
2. ALIGN INTERIOR WALL FLUSH WITH EXTERIOR FINISHED WALL.

THIS IS A COPYRIGHT DRAWING AND SHALL NOT BE REPRODUCED OR REVISED WITHOUT WRITTEN PERMISSION AND MUST BE RETURNED AT COMPLETION OF WORK OR UPON REQUEST.

THE CONTRACTOR SHALL CHECK AND VERIFY ALL DIMENSIONS AND REPORT ALL ERRORS AND OMISSIONS TO THE ARCHITECT PRIOR TO CONSTRUCTION.

DO NOT SCALE THIS DRAWING

THIS DRAWING SHALL NOT BE USED FOR CONSTRUCTION PURPOSES UNTIL SO APPROVED.

stamp / permit

client / consultant logos

NO.	Description	Date (Y/M/D)
5	Re-issued for Construction	2016-05-10
4	Issued for Construction	2014-11-07
3	Issued for Building Permit	2014-10-31
2	Issued for Tender	2014-09-11
1	Issued for DP	2014-08-25

Revisions

PROJECT TITLE
CANMORE COMMUNITY HOUSING CORPORATION

PROJECT ADDRESS
 100 Dyrkas Lane
 Canmore, AB

DRAWING TITLE
UNIT PLANS

DRAWN RS	PROJECT NUMBER 214-019
CHECKED HB	SCALE AS NOTED
DATE 2014-08-01	SHEET NO. A5.01

BRZ Partnership Architecture Inc.
 202 - 1215, 13th Street SE, Calgary, AB T2G 3J4
 P 403-532-5860 F 403-532-5864
 www.brzarchitecture.ca